

TWE 08/28/2003 3:14:17 PM SILVER SPRINGS PONDS\1 DRAWING\OPERATIONS.dwg

### SILVER SPRINGS POND

ITEM	DESCRIPTION
1	Inlet
2	Fish Migration
3	Knife Gate Valve / Trash Rack
4	Overflow / Spillway
5	Outlet piping
6	Outlet Screen

DESIGN: DMH  
 DRAWN: TME  
 CHECKED: CGN  
 SCALE: HORIZ. 1" = 100' H  
 VERT. NONE  
 DATE: AUG. 2003


ENGINEERS SEAL

REVISIONS	
NO.	DATE

MOUNTAIN REGIONAL WATER SPECIAL SERVICE DISTRICT  
 SILVER SPRINGS PONDS  
 STANDARD OPERATIONS PLAN  
 LOWER POND

**AQUA**  
 ENGINEERING, INC.  
 533 W. 2600 S., SUITE 275 BOUNTIFUL, UT 84010  
 PHONE (801) 299-1327 FAX (801) 299-0153

SHEET  
**3**

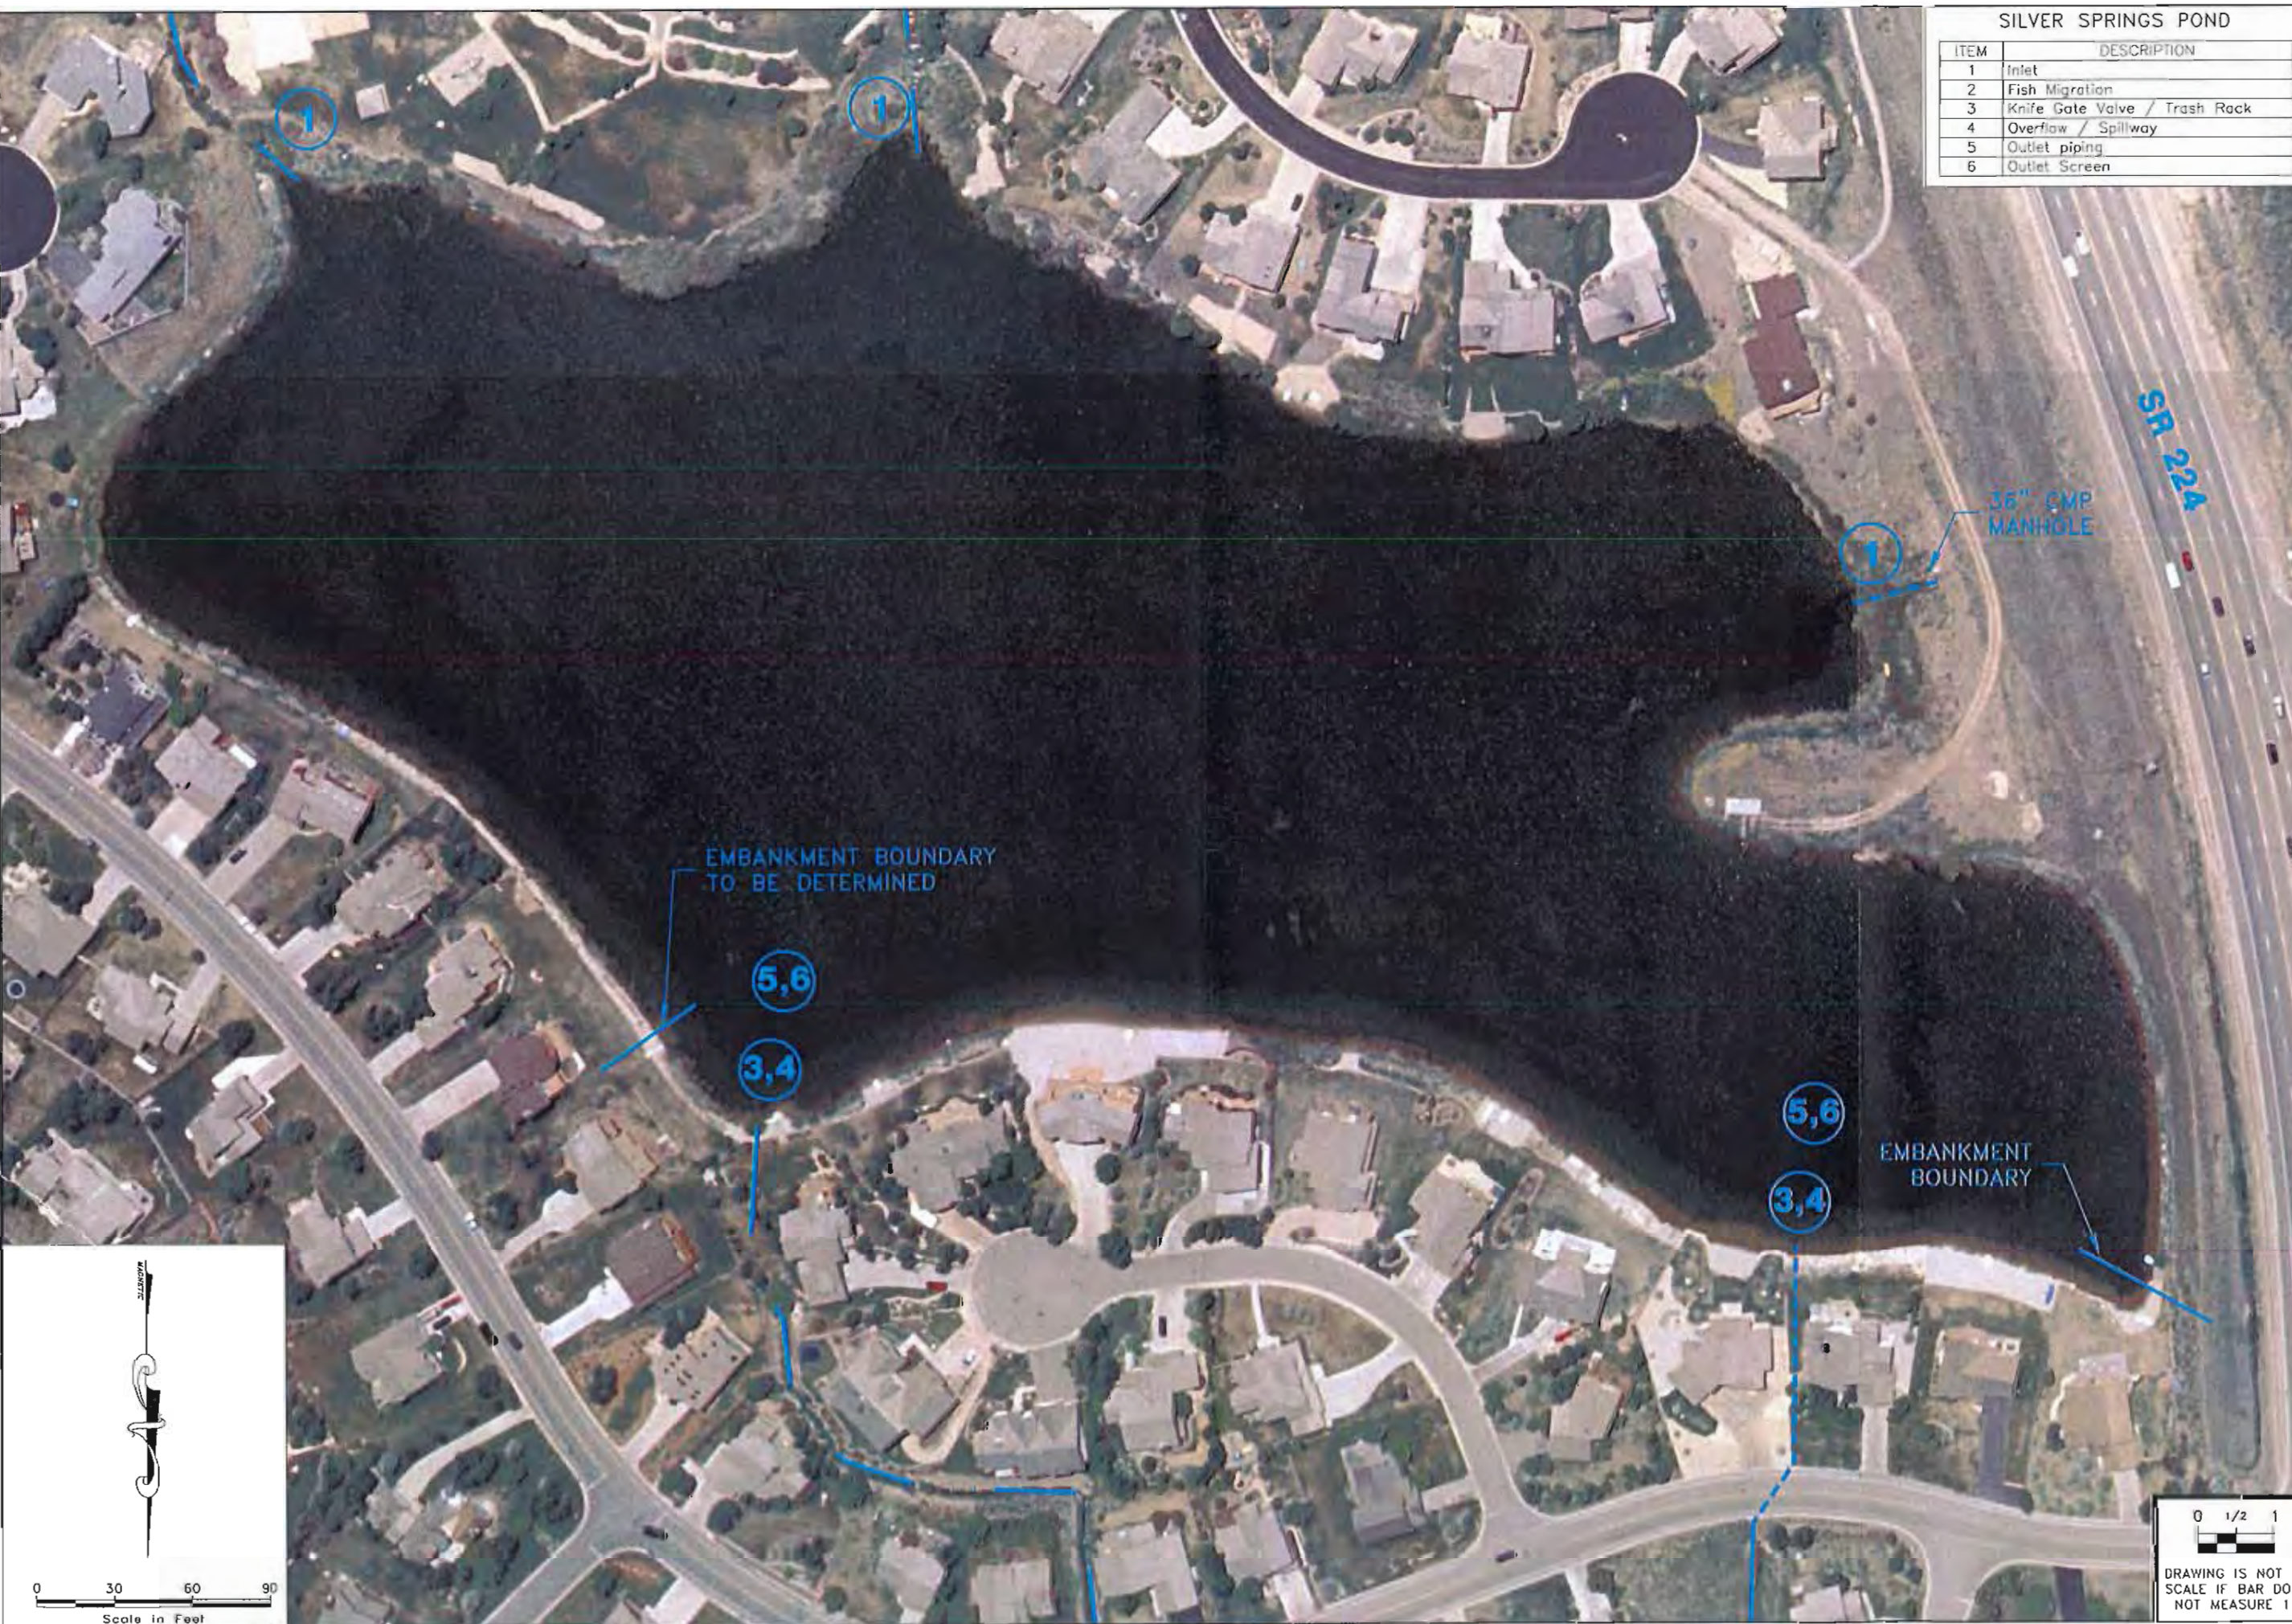

0 1/2 1  
 DRAWING IS NOT TO SCALE IF BAR DOES NOT MEASURE 1"

T:\08\_28\_2003\1.MRW SILVER SPRINGS PONDS\DRAWING\OPERATIONS.dwg



Scale in Feet  
0 100 200 300

LEGEND  
 - - - - - UNDERGROUND CULVERT  
 - - - - - OPEN CHANNEL DRAINAGE

0 1/2 1  
 DRAWING IS NOT TO SCALE IF BAR DOES NOT MEASURE 1"

DESIGN: DMH  
 DRAWN: TWF  
 CHECKED: CCM  
 SCALE: 1" = 100' H  
 DATE: 08/05/2003

NO.	REVISIONS	DATE

MOUNTAIN REGIONAL WATER SPECIAL SERVICE DISTRICT  
 SILVER SPRINGS PONDS  
 STANDARD OPERATIONS PLAN  
 GENERAL SITE PLAN

**AQUA**  
 ENGINEERING, INC.  
 533 W. 2600 S., SUITE 275 BOUNTIFUL, UT 84010  
 PHONE (801) 299-1327 FAX (801) 299-0153

SHEET  
 1

ENGINEER'S SEAL

TWE 08/28/2003 X:\MRW SILVER SPRINGS PONDS\DRAWING\OPERATIONS.dwg




SILVER SPRINGS POND	
ITEM	DESCRIPTION
1	Inlet
2	Fish Migration
3	Knife Gate Valve / Trash Rack
4	Overflow / Spillway
5	Outlet piping
6	Gullet Screen

DESIGN: DMH  
 DRAWN: TWE  
 CHECKED: CGN  
 SCALE: 1" = 100' H  
 DATE: AUG. 2003

REVISIONS	
NO.	DATE

MOUNTAIN REGIONAL WATER SPECIAL SERVICE DISTRICT  
 SILVER SPRINGS PONDS  
 STANDARD OPERATIONS PLAN  
 UPPER POND

**AQUA**  
 ENGINEERING, INC.  
 533 W. 2600 S., SUITE 275 BOUNTIFUL, UT 84010  
 PHONE (801) 298-1327 FAX (801) 298-0153

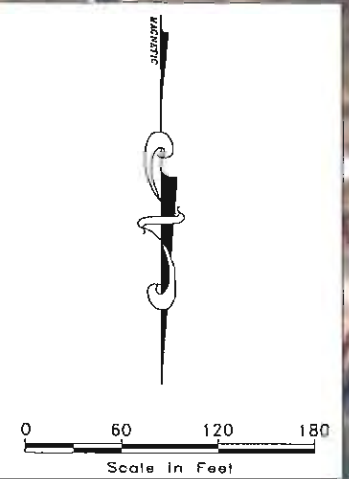

0 1/2 1  
 DRAWING IS NOT TO SCALE IF BAR DOES NOT MEASURE 1"

SHEET  
 2